



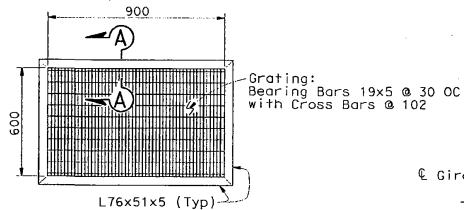


DIST	COUNTY	ROUTE	KILOMETER POST TOTAL PROJECT	SHEET NO.	TOTAL SHEETS
11	SD	15	M38.7/M42.7	682	822
			10-5-04		
			4-12-04		
			PLANS APPROVAL DATE		
			REGISTERED CIVIL ENGINEER		
			REGISTERED PROFESSIONAL ENGINEER		
			No. 060444		
			Exp. 06-30-05		
			CIVIL		
			STATE OF CALIFORNIA		


The State of California or its officers or agents shall not be responsible for the accuracy or completeness of electronic copies of this plan sheet.

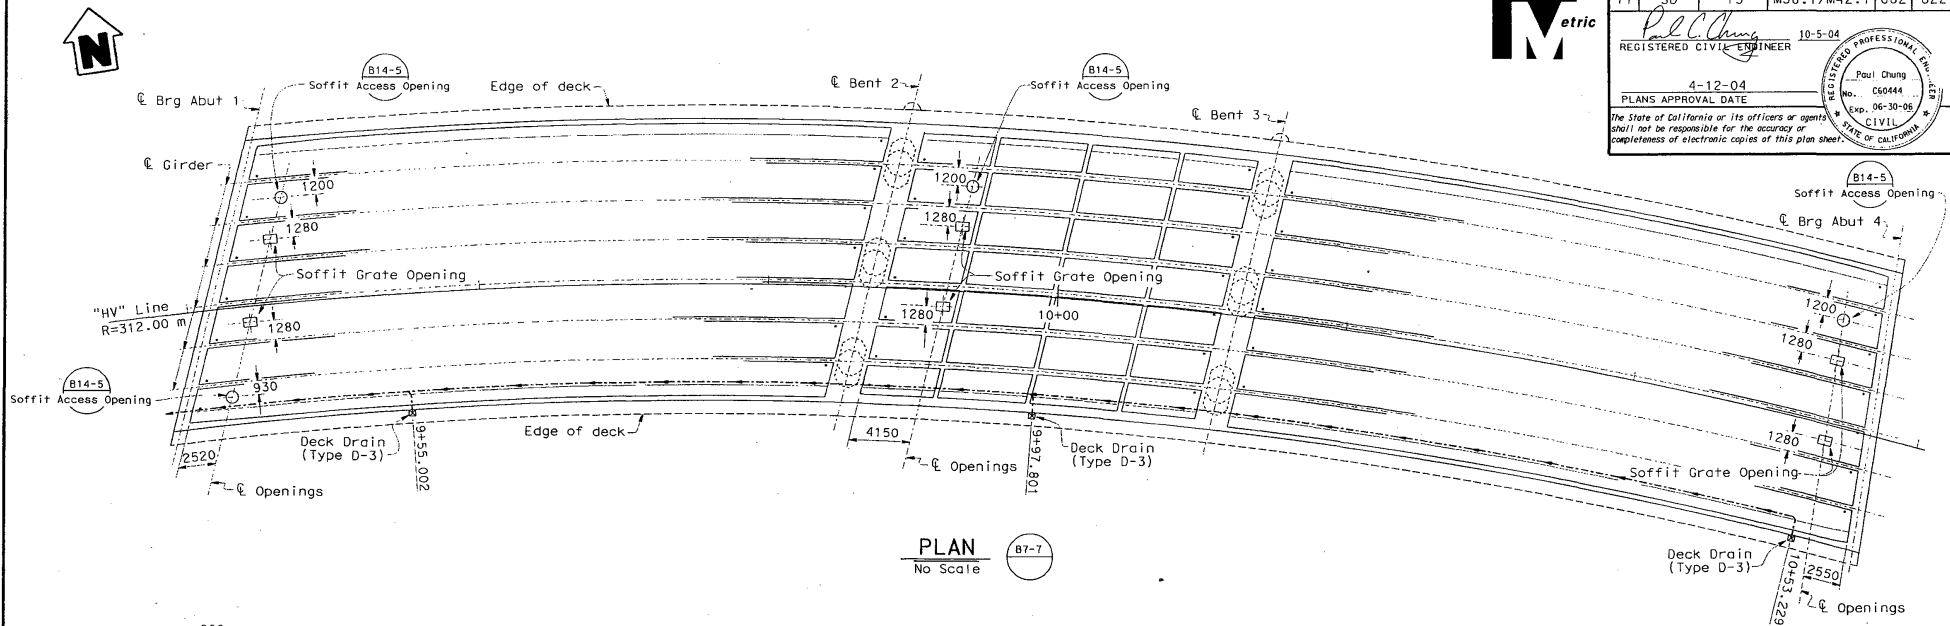


GRATE PLAN
No Scale

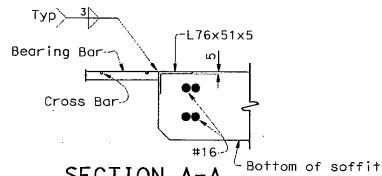


SECTION A-A
No Scale

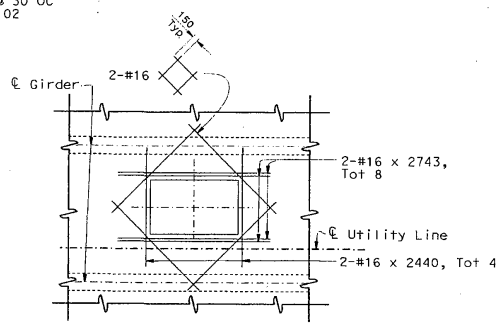


PLAN (SOFFIT GRATE OPENING)
No Scale

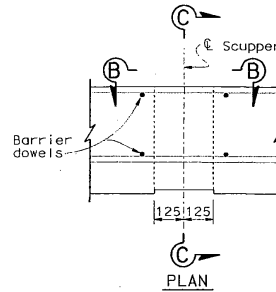

PLAN

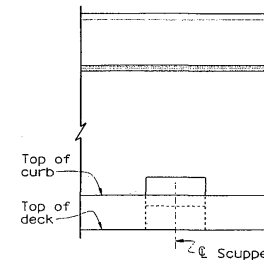

VIEW B-B

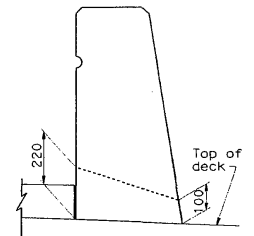

SECTION C-C

SCUPPER DETAILS
1:10

Note:
Scuppers to be placed every 2.4 meters along Concrete Barrier Type 736R (Mod)

ALL DIMENSIONS ARE IN MILLIMETERS UNLESS OTHERWISE SHOWN

PHASE 2

DESIGN	BY A. Logus	CHECKED Jaspal Kalkat
DETAILS	BY Dale Kubochi	CHECKED Traci Holden
QUANTITIES	BY A. Logus	CHECKED Gabriel Gale

STATE OF CALIFORNIA
DEPARTMENT OF TRANSPORTATION

DIVISION OF STRUCTURES
STRUCTURE DESIGN 15

BRIDGE NO.	57-1129
KP (PM)	42.92(26.27)

HIGHLAND ROAD OC (REPLACE)
DECK DRAINAGE LAYOUT

STRUCTURES DESIGN DETAIL SHEET (METRIC) REV. 4/20/00

ORIGINAL SCALE IN MILLIMETERS FOR REDUCED PLANS

CU 11
EA 080921

DISREGARD PRINTS BEARING EARLIER REVISION DATES

REVISION DATES (PRELIMINARY STAGE ONLY)

SHEET	30	OF	41
-------	----	----	----

DATE PLOTTED = 12-OCT-2004 TIME PLOTTED = 1:47:36 USERNAME = 1100